



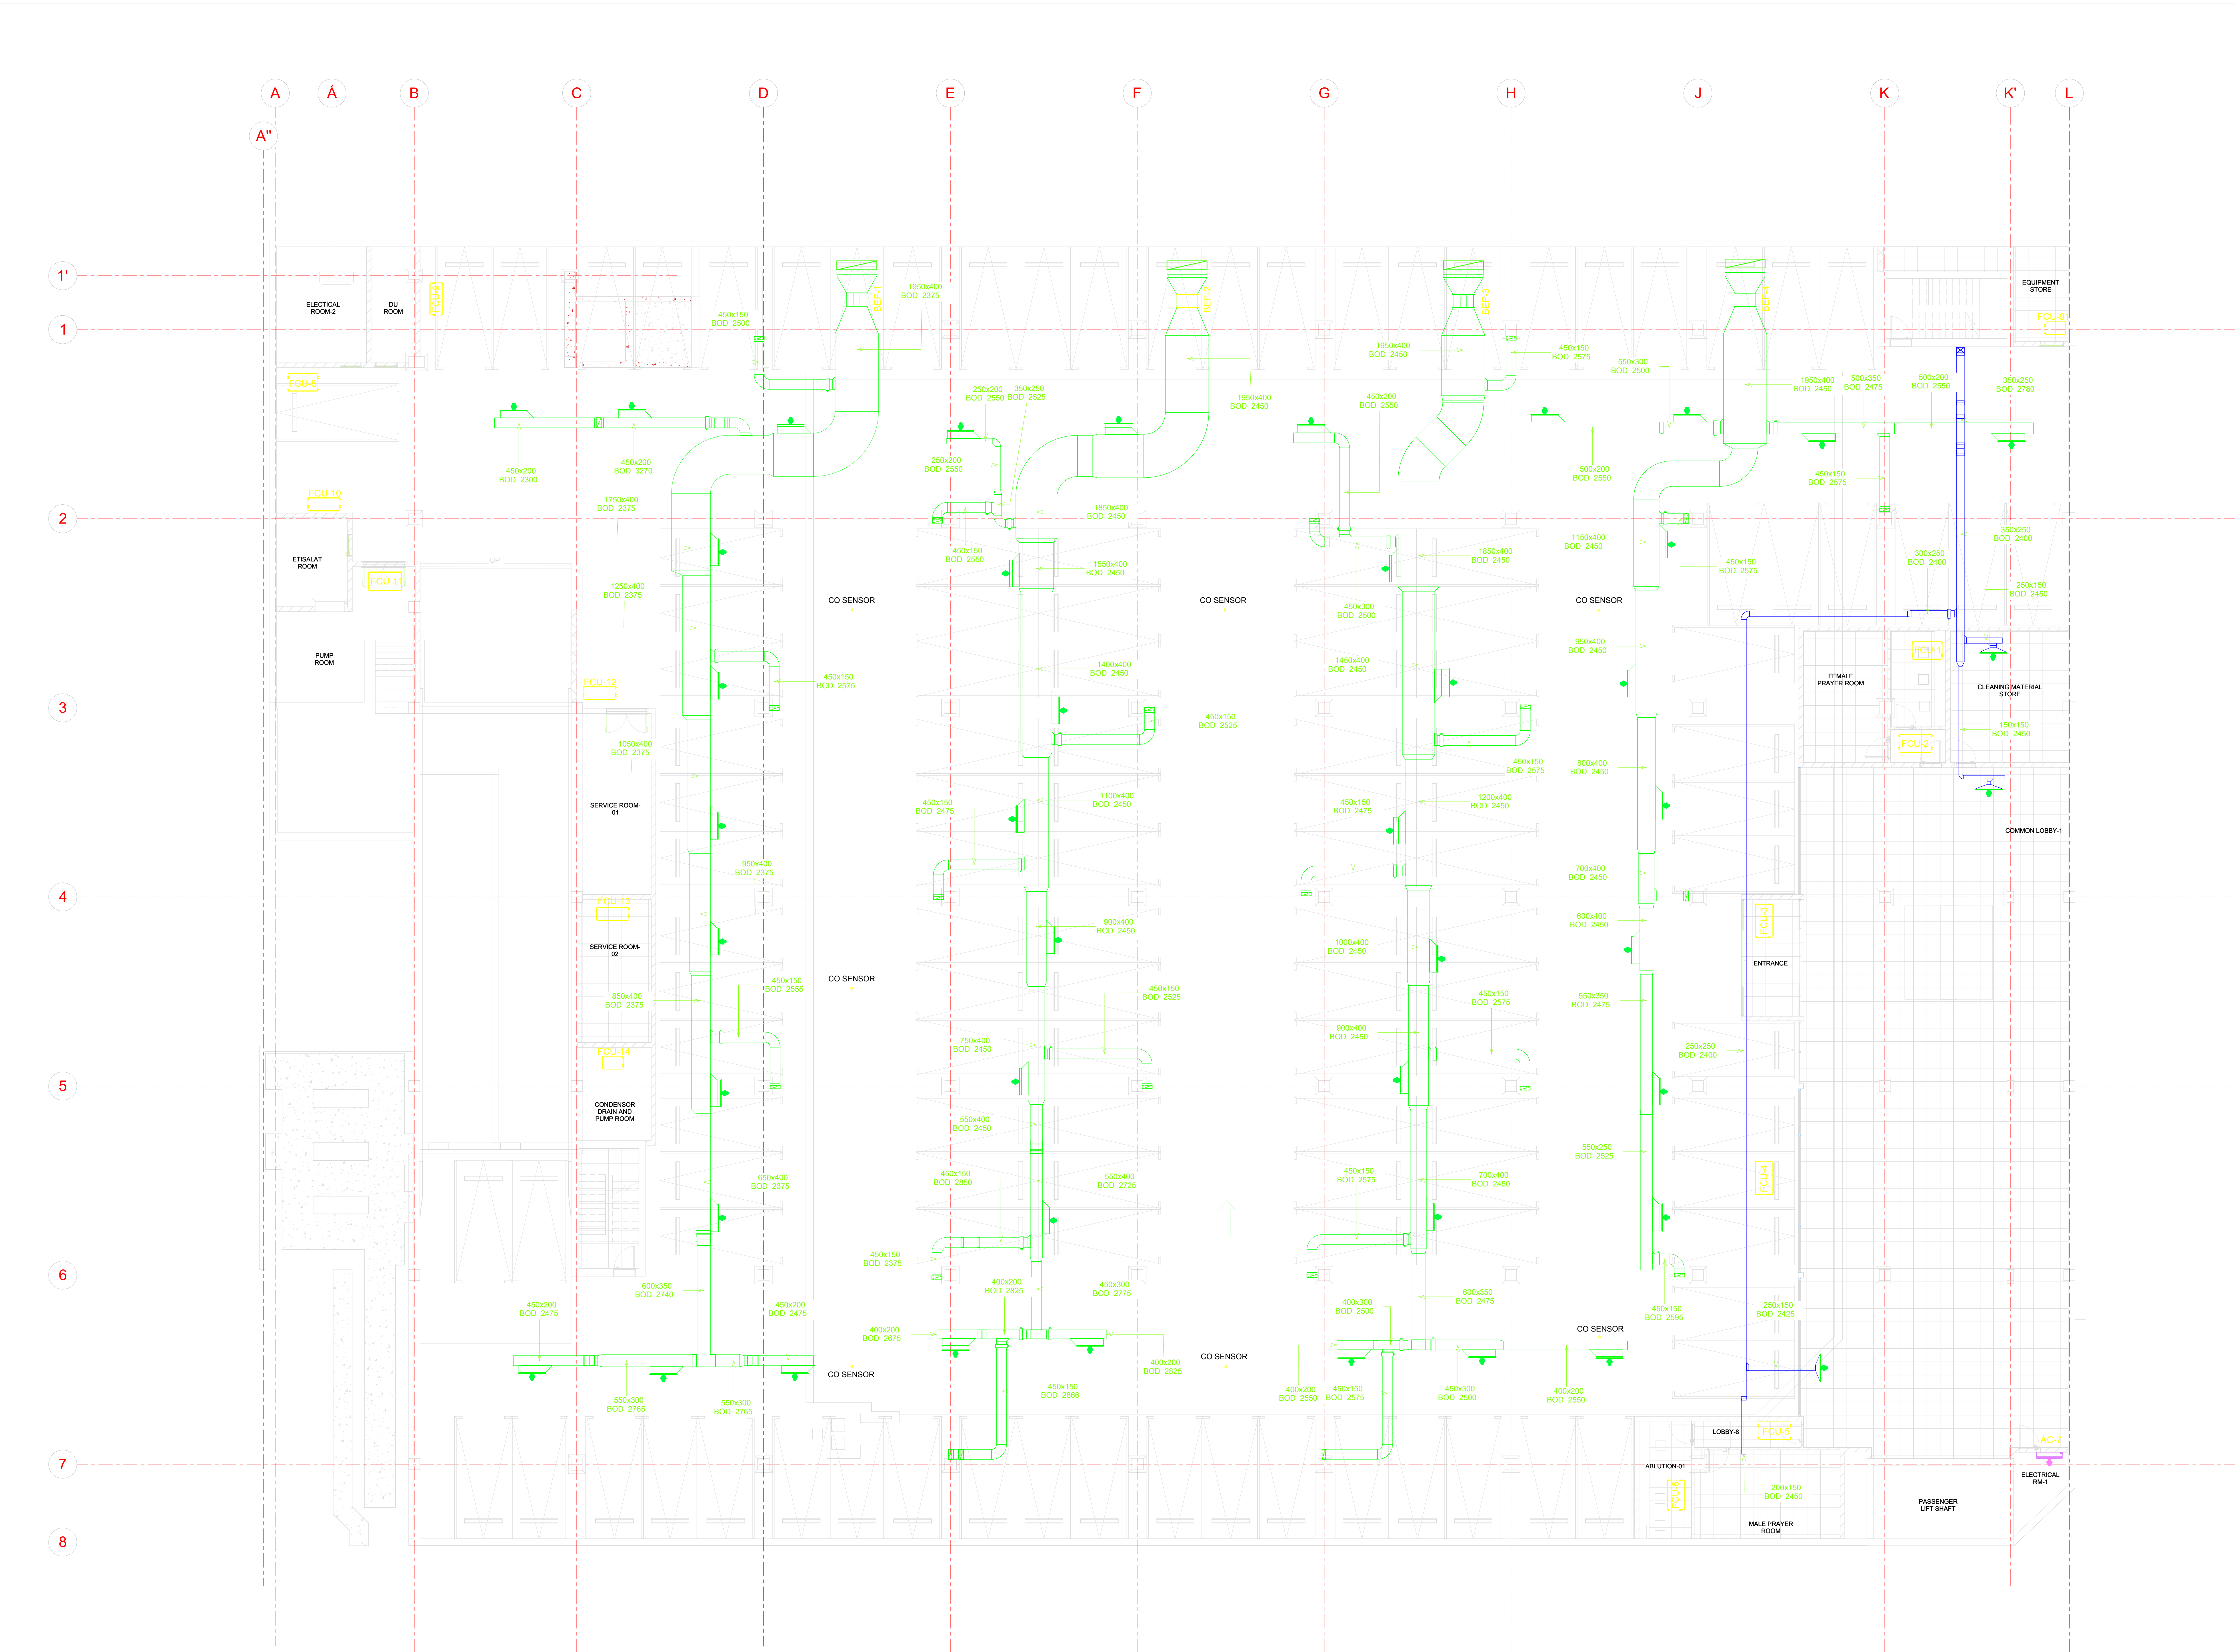

DM STAMP:

KEY PLAN

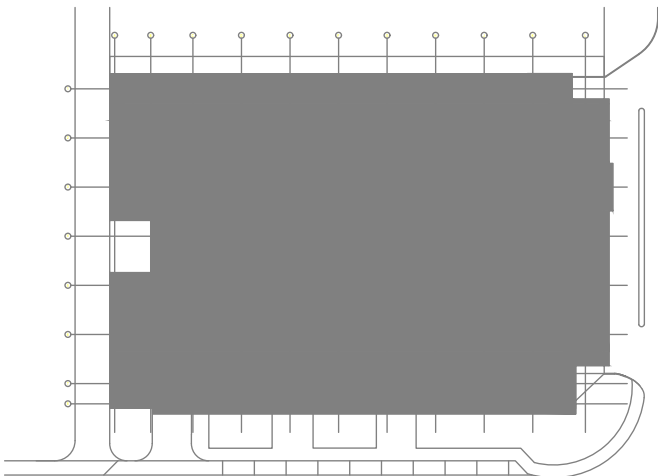

GENERAL NOTES:

1. THIS DRAWING IS THE COPYRIGHT OF ADS ARCHITECTURAL CONSULTANTS (DUBAI) AND MUST NOT BE RETAINED, COPIED OR USED WITHOUT THE ABOVE CONSULTANT'S AUTHORITY.
2. DO NOT SCALE FROM THE DRAWINGS.
3. ALL DIMENSIONS ARE IN MILLIMETRES AND LEVELS IN METRES UNLESS NOTED OTHERWISE. ALL DIMENSIONS TO BE VERIFIED ON SITE & APPROVED BY THE ENGINEER.

Rev	Description	Drawn	Checked	Authorised

Purpose of Issue	Rev	Date	Authorised

Project: **PROPOSED HYPERMARKET AT AL-RASHIDIYA, DUBAI PLOT NO: 216-2368**

Client: **H.E. MOHAMMED JUMA SAEED AL NABOODAH**

Contractor: **Civil Matrix Contracting LLC**
Tel: 2563380 Fax: 2563381
P.O. Box: 121783 Dubai, UAE
WEB: www.civilmatrixco.com

Consultant: **ADS ARCHITECTURAL CONSULTANTS**
Office No. 708, Clover Bay,
Al Abraj Street, Business Bay,
P.O. Box 124616, Dubai, UAE.
Tel: +9714 5516517
e-mail: info@adsarch.com

Drawing title:

Original Scale	Drawn	Checked	Authorised	Size
1:100	Date: 11/03/17	Date: 11/03/17	Date: 11/03/17	A0
Drawing Number				Rev
BASEMENT FLOOR VENTILATION PLAN				00